



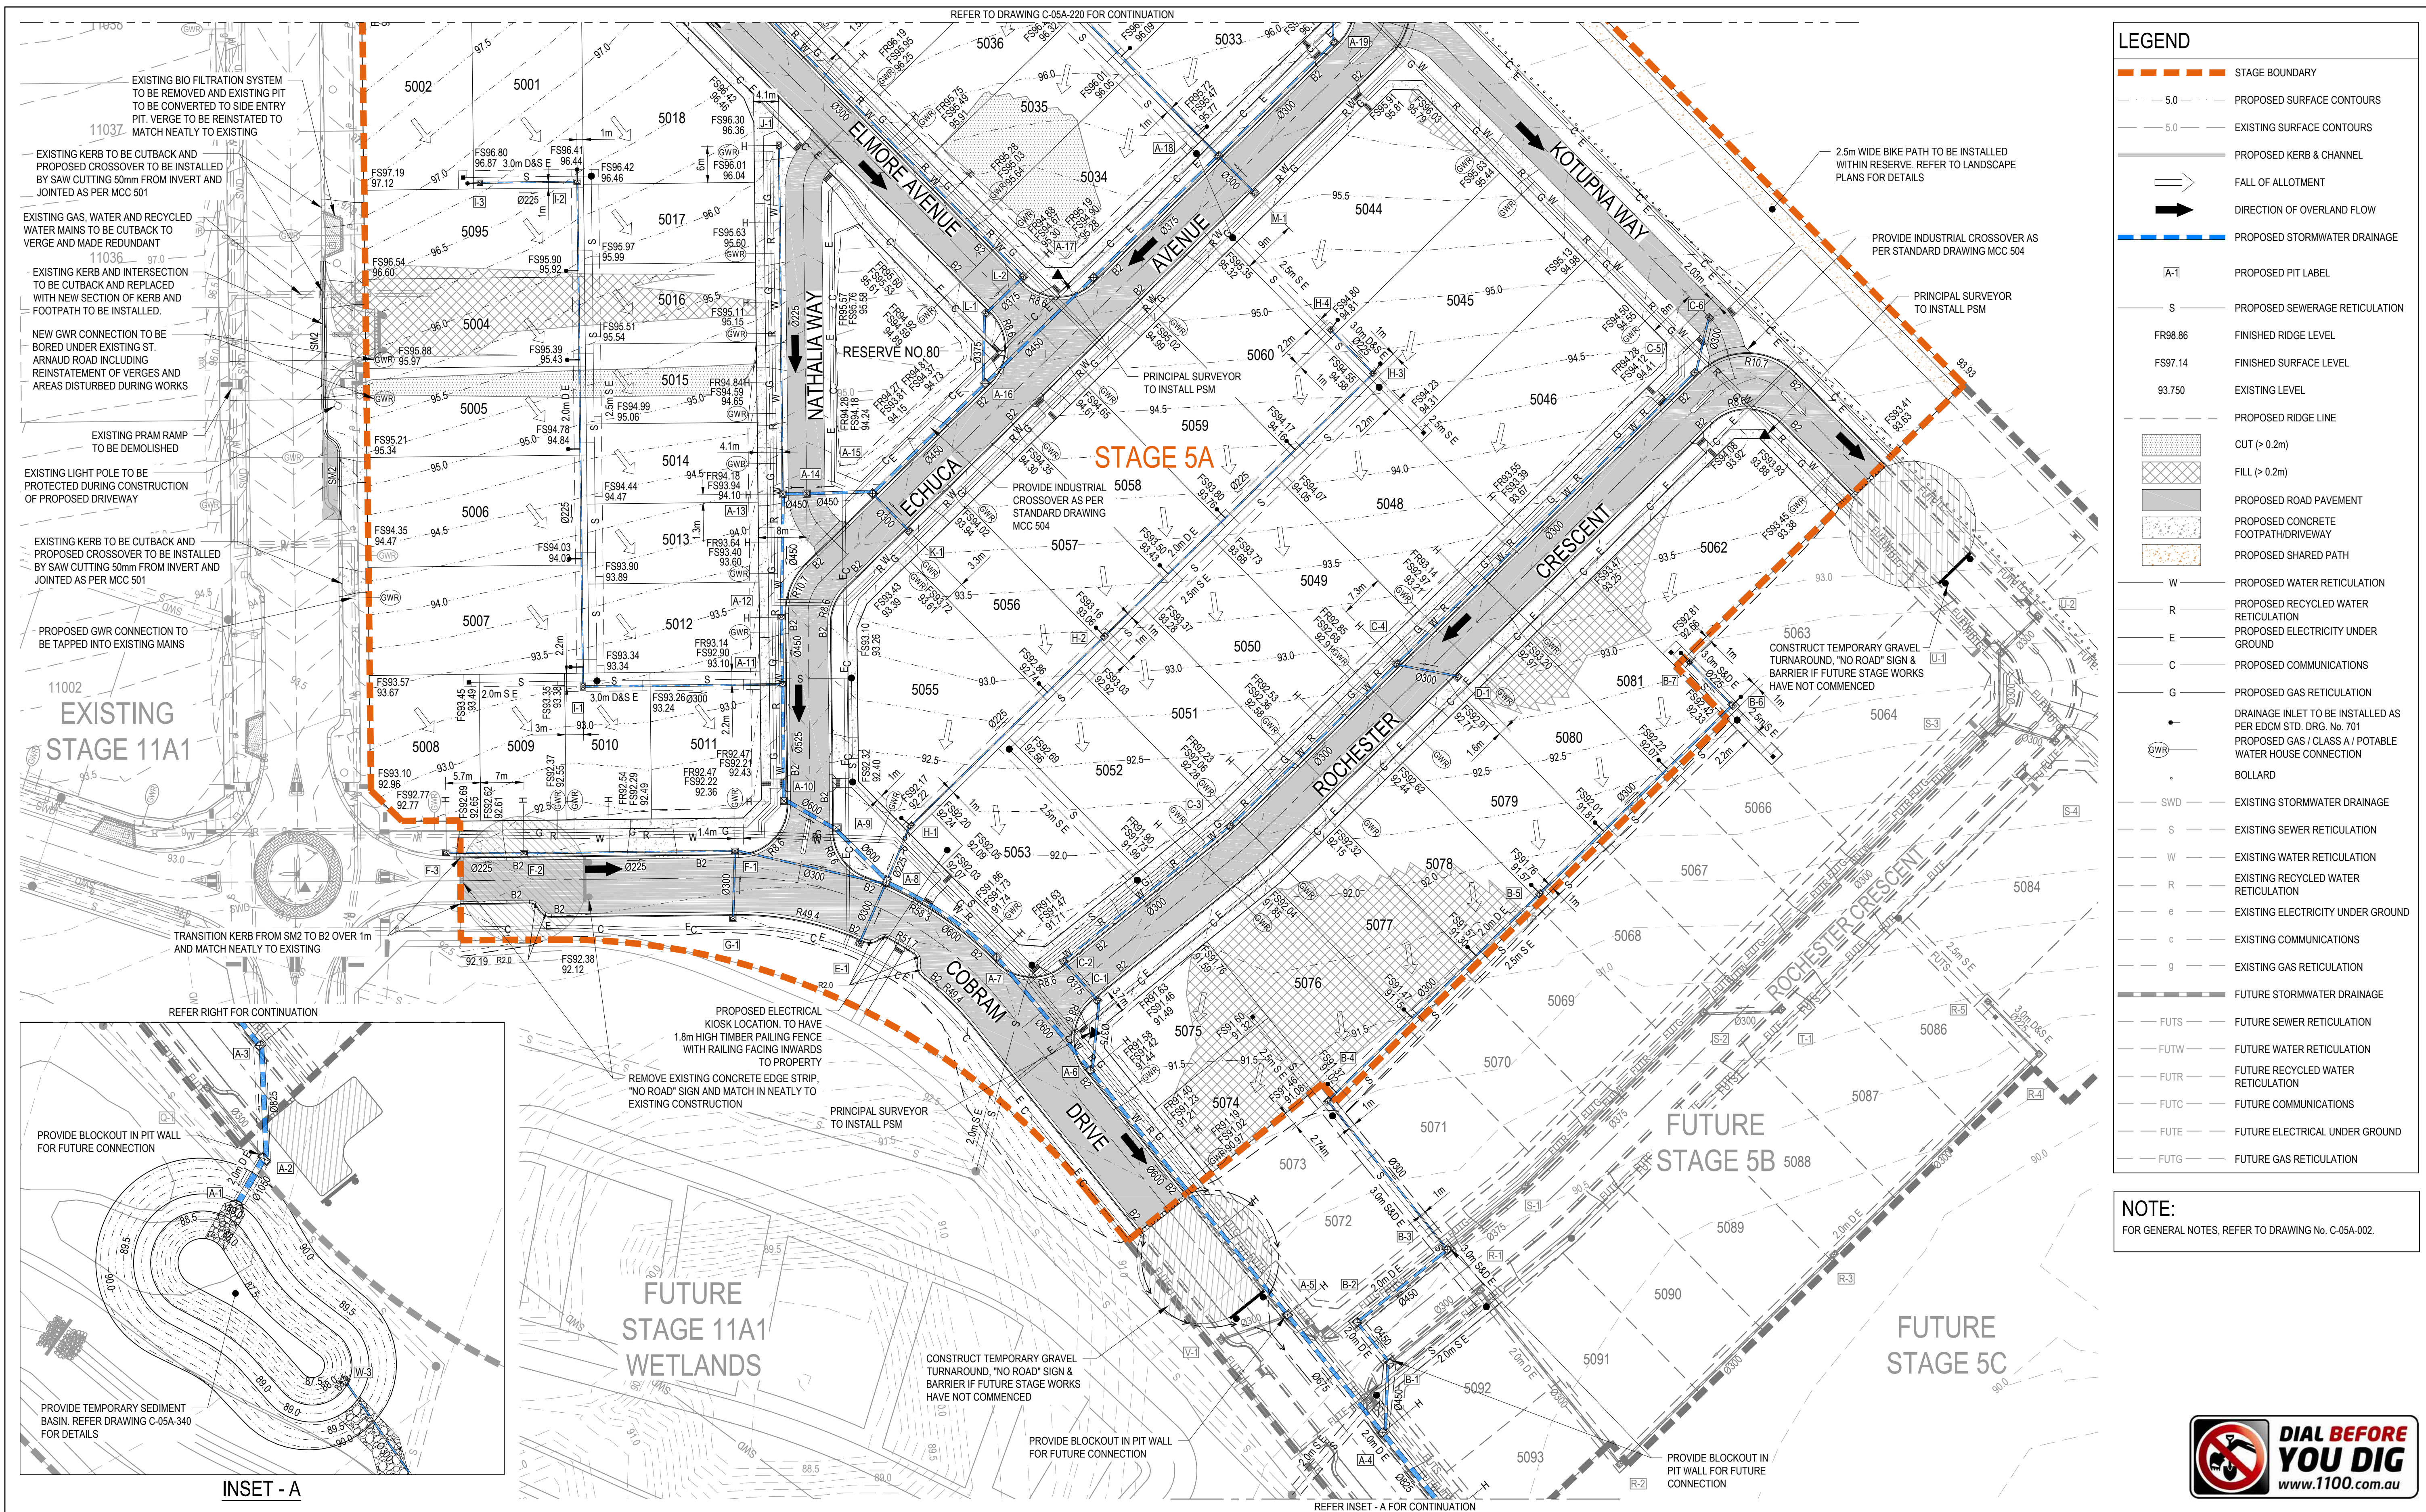

05	UPDATED EASEMENT ON LOT 5020, 5045 & 5046	WB	ZS	SE 17.10.19
04	FOOTPATH TACTILES REVISED	WB	ZS	SE 09.10.19
03	RESPONSE TO ADDITIONAL COUNCIL COMMENTS	WB	ZS	SE 13.09.19
02	RESPONSE TO COUNCIL COMMENTS	MD	ZS	SE 26.07.19
01	ISSUED TO COUNCIL FOR APPROVAL	MD	ZS	SE 31.05.19
Issue	Description	By	Ckd	PM Date

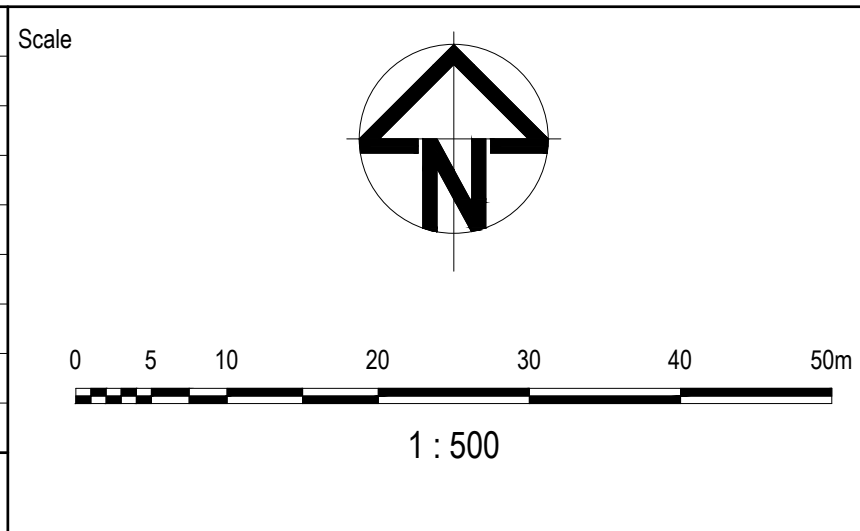

Planner

RD RobertsDay
planning.design.place

Filename C-05a-220-10029435-Roadworks&DrainagePlan.dwg

Client

The logo for Resimax Group features the company name in white, bold, sans-serif capital letters. The word "RESIMAX" is on the top line, and "GROUP" is on the bottom line. The text is set against a solid red rectangular background. The bottom-left corner of the red rectangle is cut off at a 45-degree angle.

Status	FOR APPROVAL CONSTRUCTION SUBJECT TO APPROVAL		
Verifier	Z.STROGUSZ		
Scales	1:500	Original Issue Signatures	
Original Size	A1	Drawn W.BUMAGAT	
Height Datum	AHD	Designed J.ROCK	
Grid	MGA	Project Manager S.EISEL	
		© Copyright reserved	

Project	EYNESBURY TOWNSHIP STAGE 5A
Title	ROADWORKS AND DRAINAGE LAYOUT PLAN SHEET 2 OF 2



ARCADIS

Arcadis Australia Pacific Pty Limited
 Level 32, 140 William Street
 Melbourne VIC 3000
 ABN 76 104 485 289

Tel No: +61 3 8623 4000

www.arcadis.com

Drawing No.	Project No.	Issue
C-05A-221	10029435	05